

KEY

- △ Fire Alarm
- F/E Fire Exit
- Extinguisher (Water)
- Extinguisher (Carbon Dioxide)

SCALE

1:133 @ A3

DRAWN

Jon

DATE

1/05/03

APPD

DATE

CLIENT

Gibson Hall

TITLE

Gibson Hall Floor Plans

**Creative Workhouse Ltd**


Stanford Rivers Ongar Essex CM5 9PJ  
 Tel: +44 (0) 1277 366858 Fax: +44 (0) 1277 366359  
 E-mail: mail@creativeworkhouse.com

DRG No

Lower Ground Floor

SHEET 2

OF 3

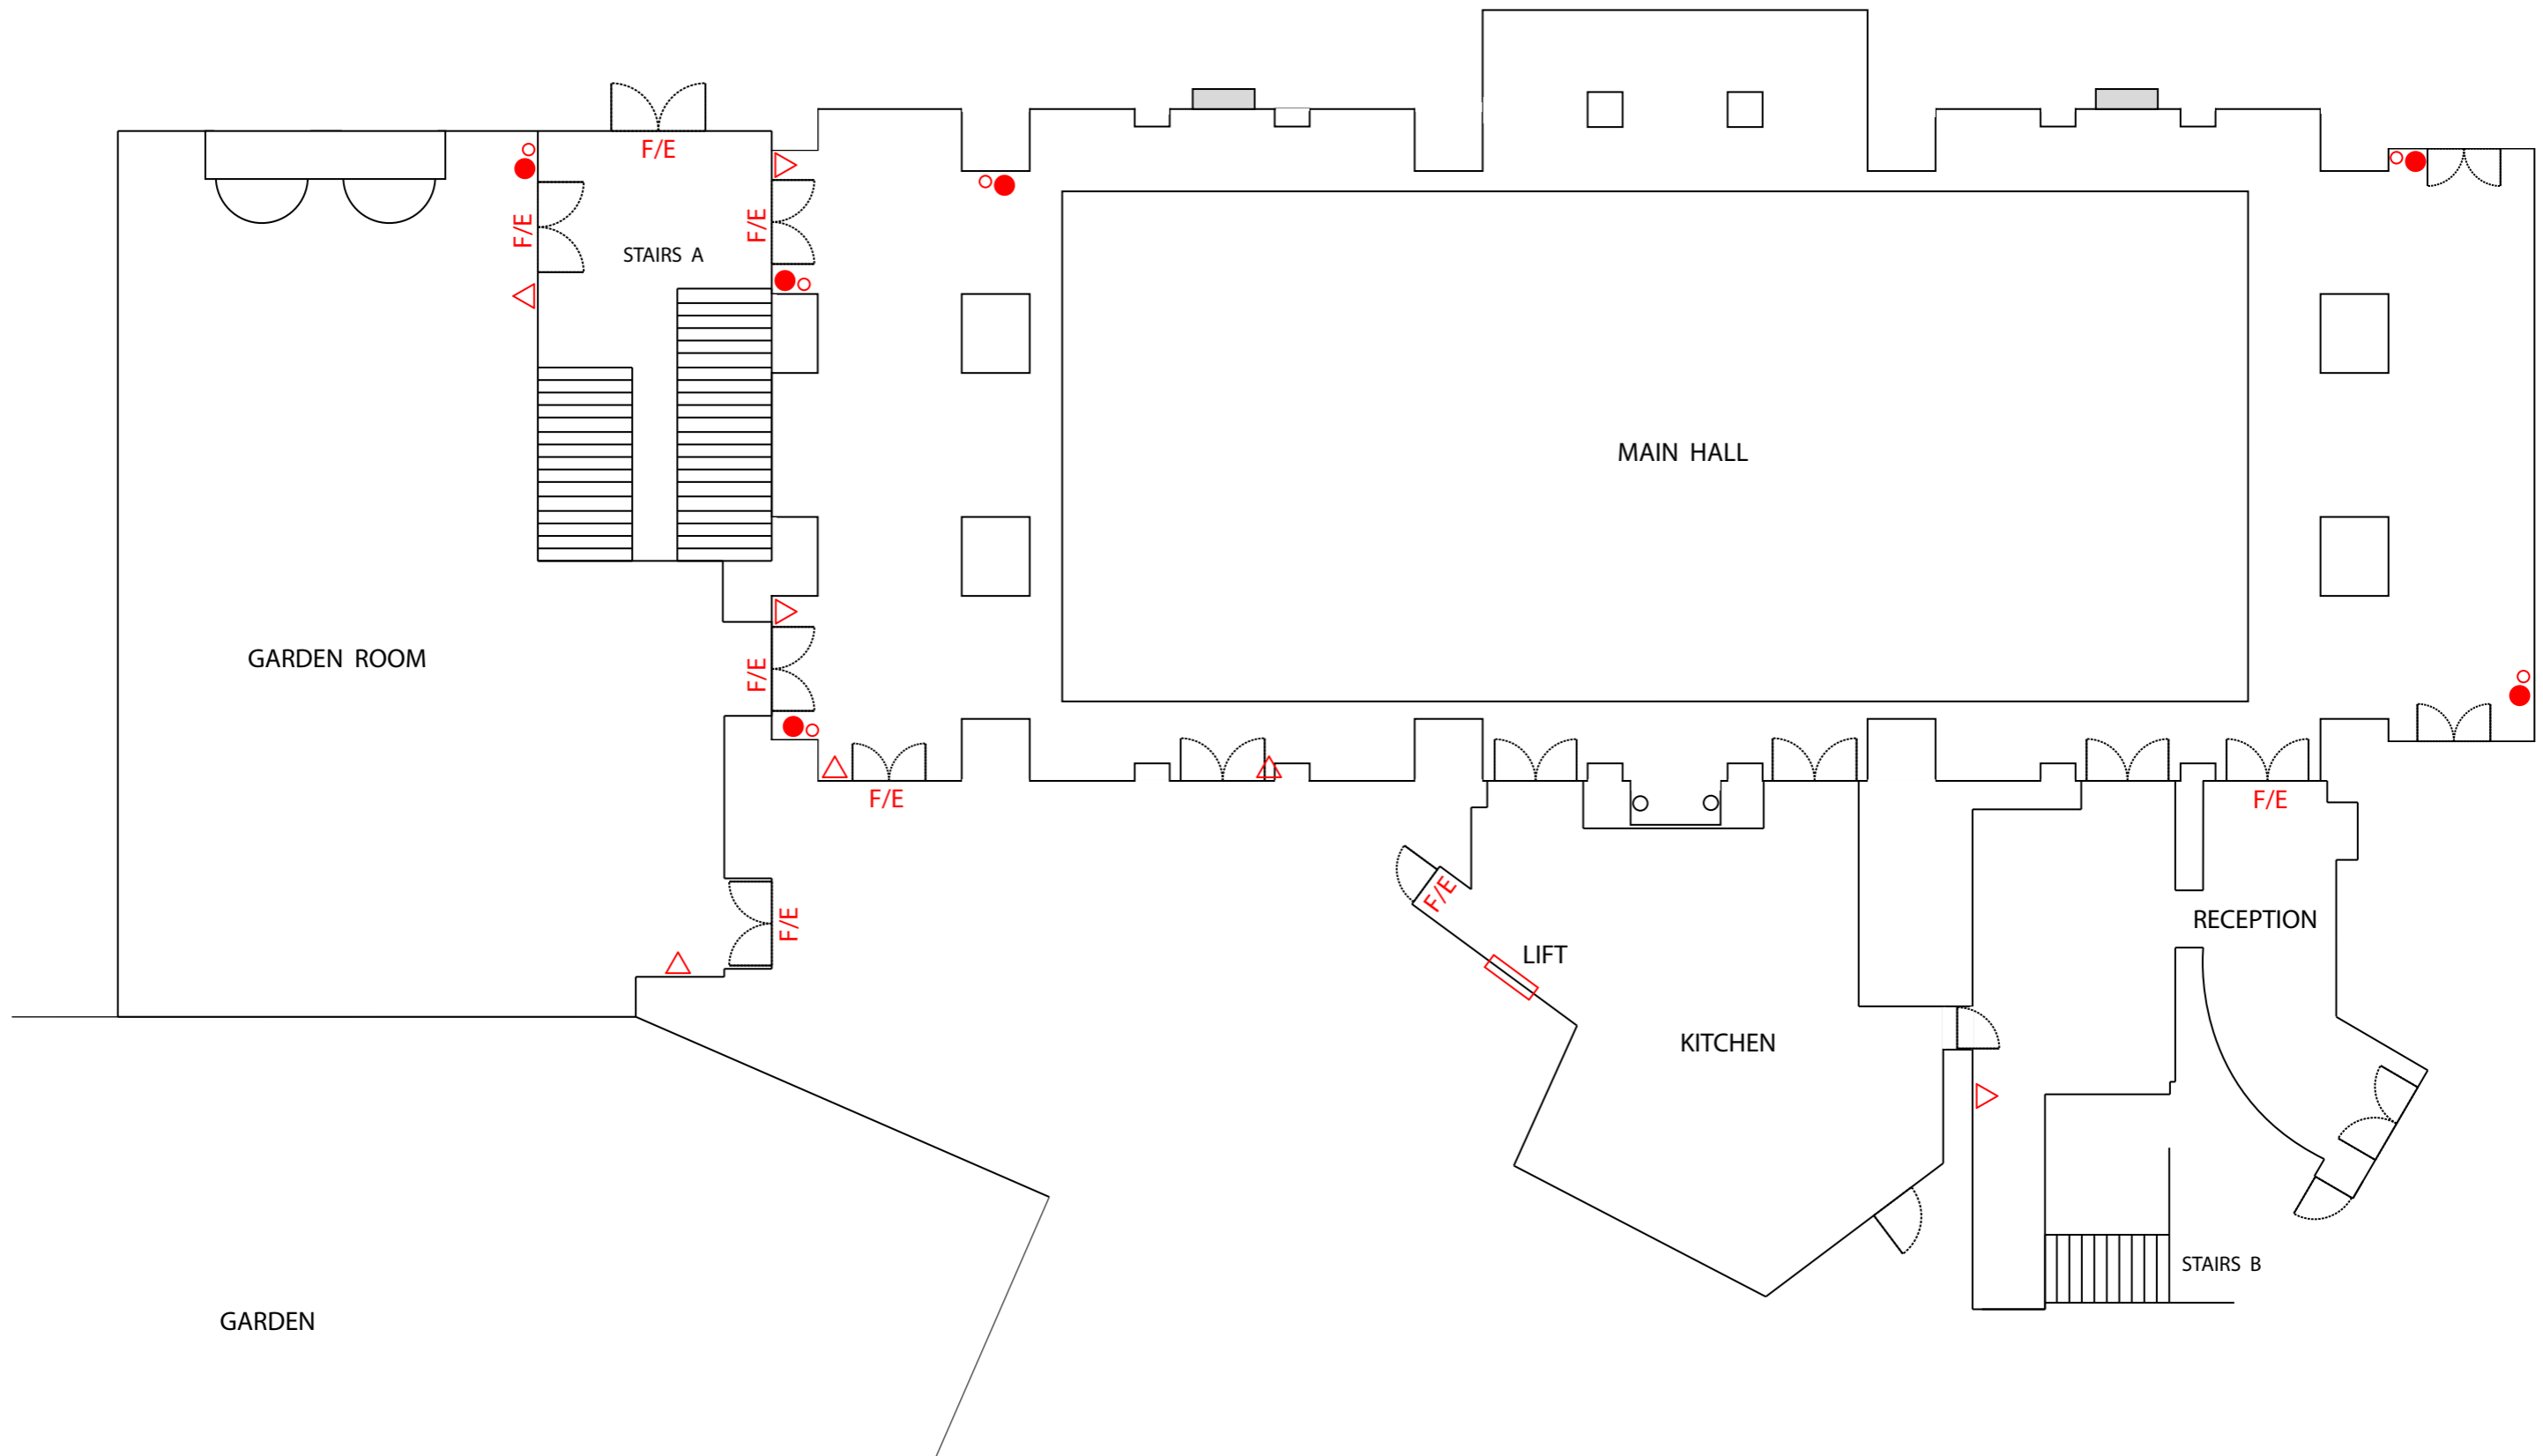

**KEY**

- △ Fire Alarm
- F/E Fire Exit
- Extinguisher (Water)
- Extinguisher (Carbon Dioxide)

**SCALE**

1:133 @ A3

**DRAWN**

Jon

**DATE**

1/05/03

**APPD**

**DATE**

**CLIENT**

Gibson Hall

**TITLE**

Gibson Hall Floor Plans

**Creative Workhouse Ltd**

Stanford Rivers Ongar Essex CM5 9PJ

Tel: +44 (0) 1277 366858 Fax: +44 (0) 1277 366359

E-mail: mail@creativeworkhouse.com

**DRG No**

Main Hall  
&  
Garden Room

SHEET 1

OF 3